


SECTION-AA'



CEILING LAYOUT- for MAIN BRANCH OFFICE

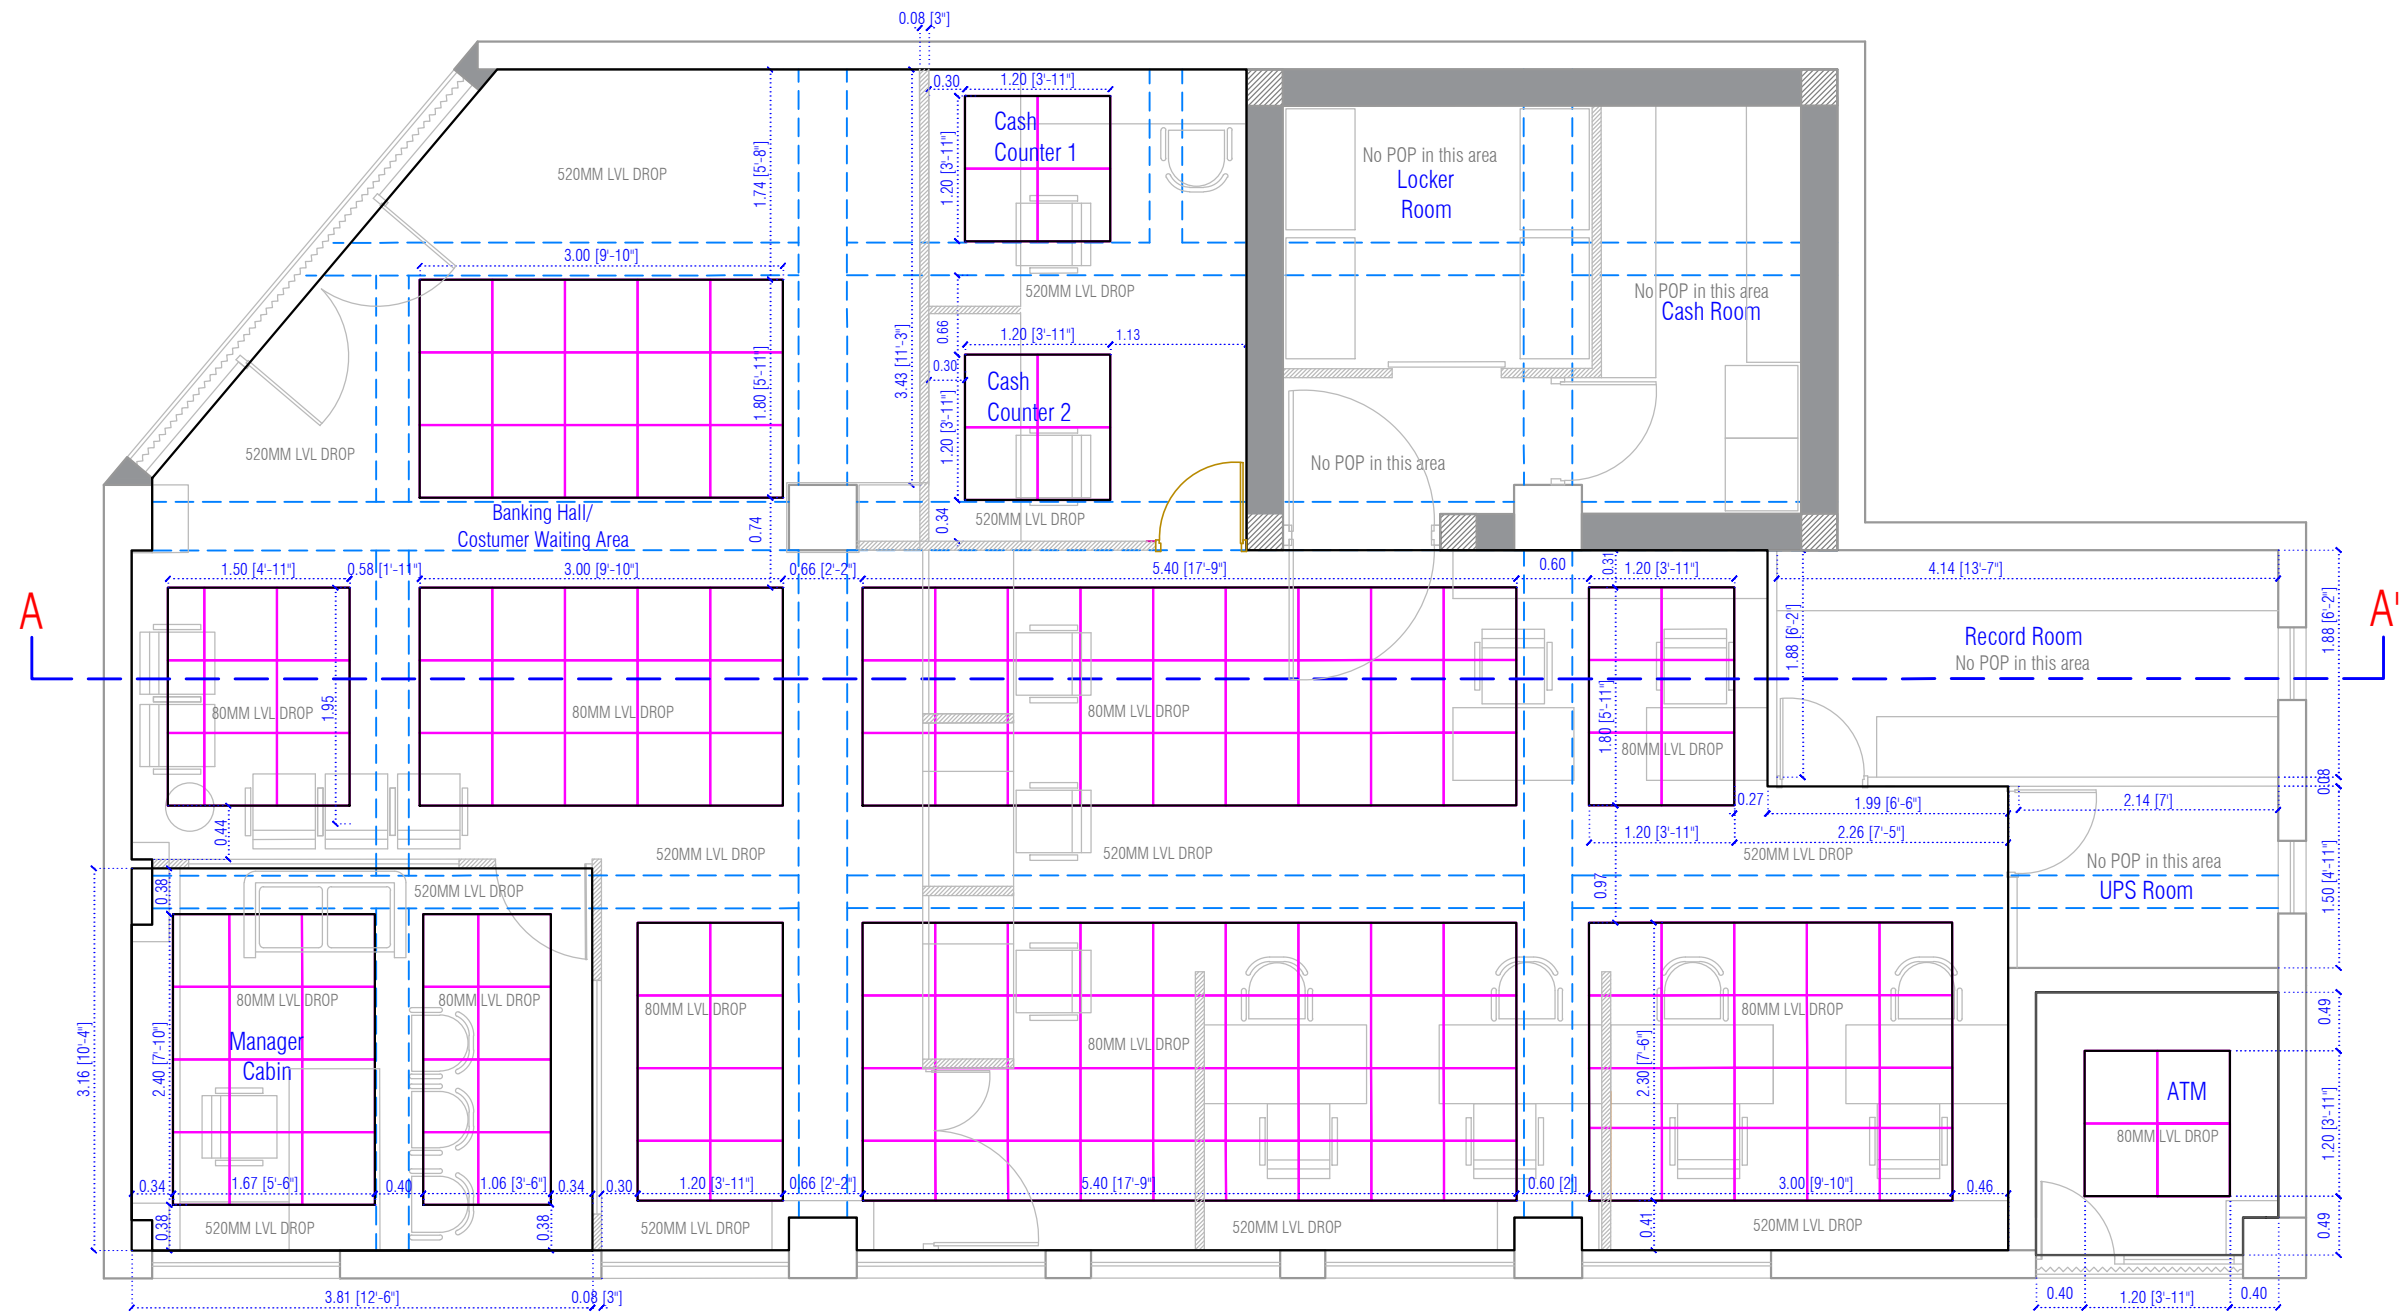

ARC-HOUSE
AR. ROHIT A. RATHI
 B.ARCH.,PGP-ACM, IBBI REG. VALUER

OFFICE ADDRESS :-
 37, MOHATA MARKET, BELOW UNION BANK OF INDIA,
 WARDHA.
 402, VIGNESH SQUARE, OPPOSITE DINANATH
 SCHOOL, DHANTOLI, NAGPUR.
 CONTACT NO.7095776840, Email ID: ar.rathirohit@gmail.com

SHEET TITLE:-
CEILING LAYOUT


DATE:- 18/03/2023

DRAWN BY:- Ar.VEDANT M.

BELONGS TO:-
**Bank Of Maharashtra, Main
 Branch Office, Amravati**

A3

PAGE NO.

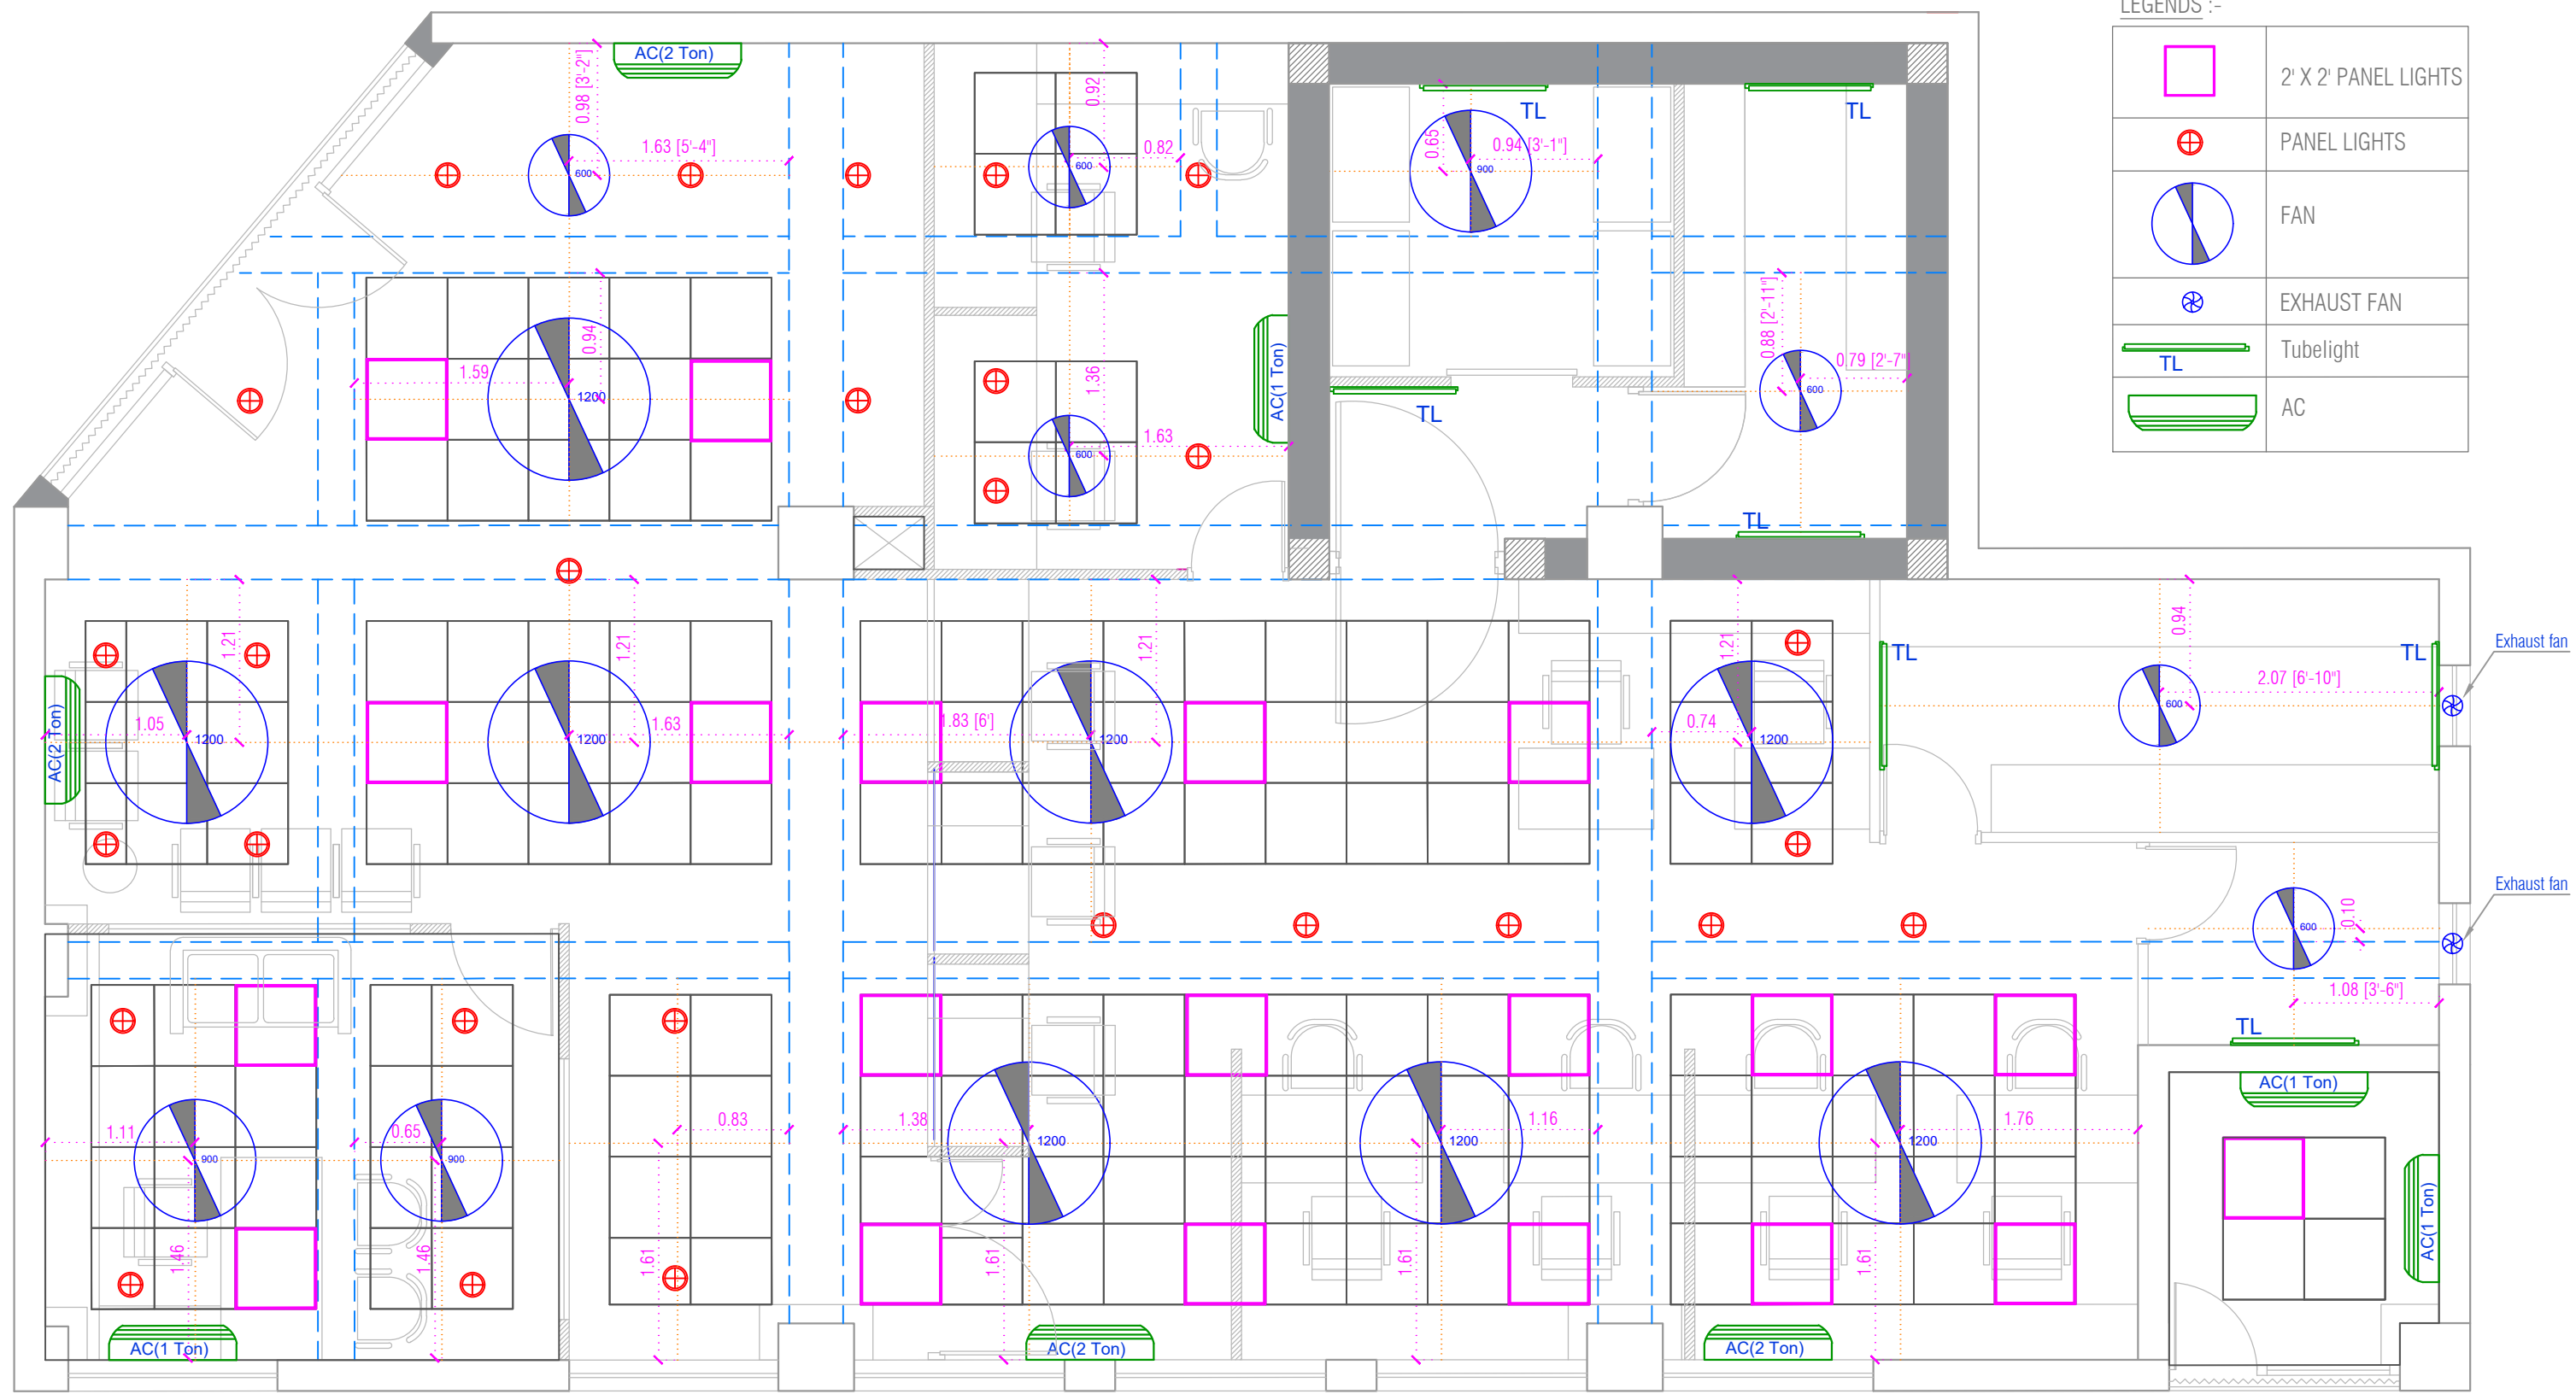

LEGENDS :-

	2' X 2' PANEL LIGHTS
	PANEL LIGHTS
	FAN
	EXHAUST FAN
	Tubelight
	AC

LIGHTING LAYOUT- for MAIN BRANCH OFFICE



ARC-HOUSE
AR. ROHIT A. RATHI
 B.ARCH.,PGP-ACM, IBBI REG. VALUER

OFFICE ADDRESS :-
 37, MOHATA MARKET, BELOW UNION BANK OF INDIA,
 WARDHA.
 402, VIGNESH SQUARE, OPPOSITE DINANATH
 SCHOOL, DHANTOLI, NAGPUR.
 CONTACT NO.7095776840, Email ID: ar.rathirohit@gmail.com

SHEET TITLE:-
LIGHTING LAYOUT


DATE:- 18/03/2023

DRAWN BY:- Ar.VEDANT M.

BELONGS TO:-
**Bank Of Maharashtra, Main
 Branch Office, Amravati**

A3

PAGE NO.

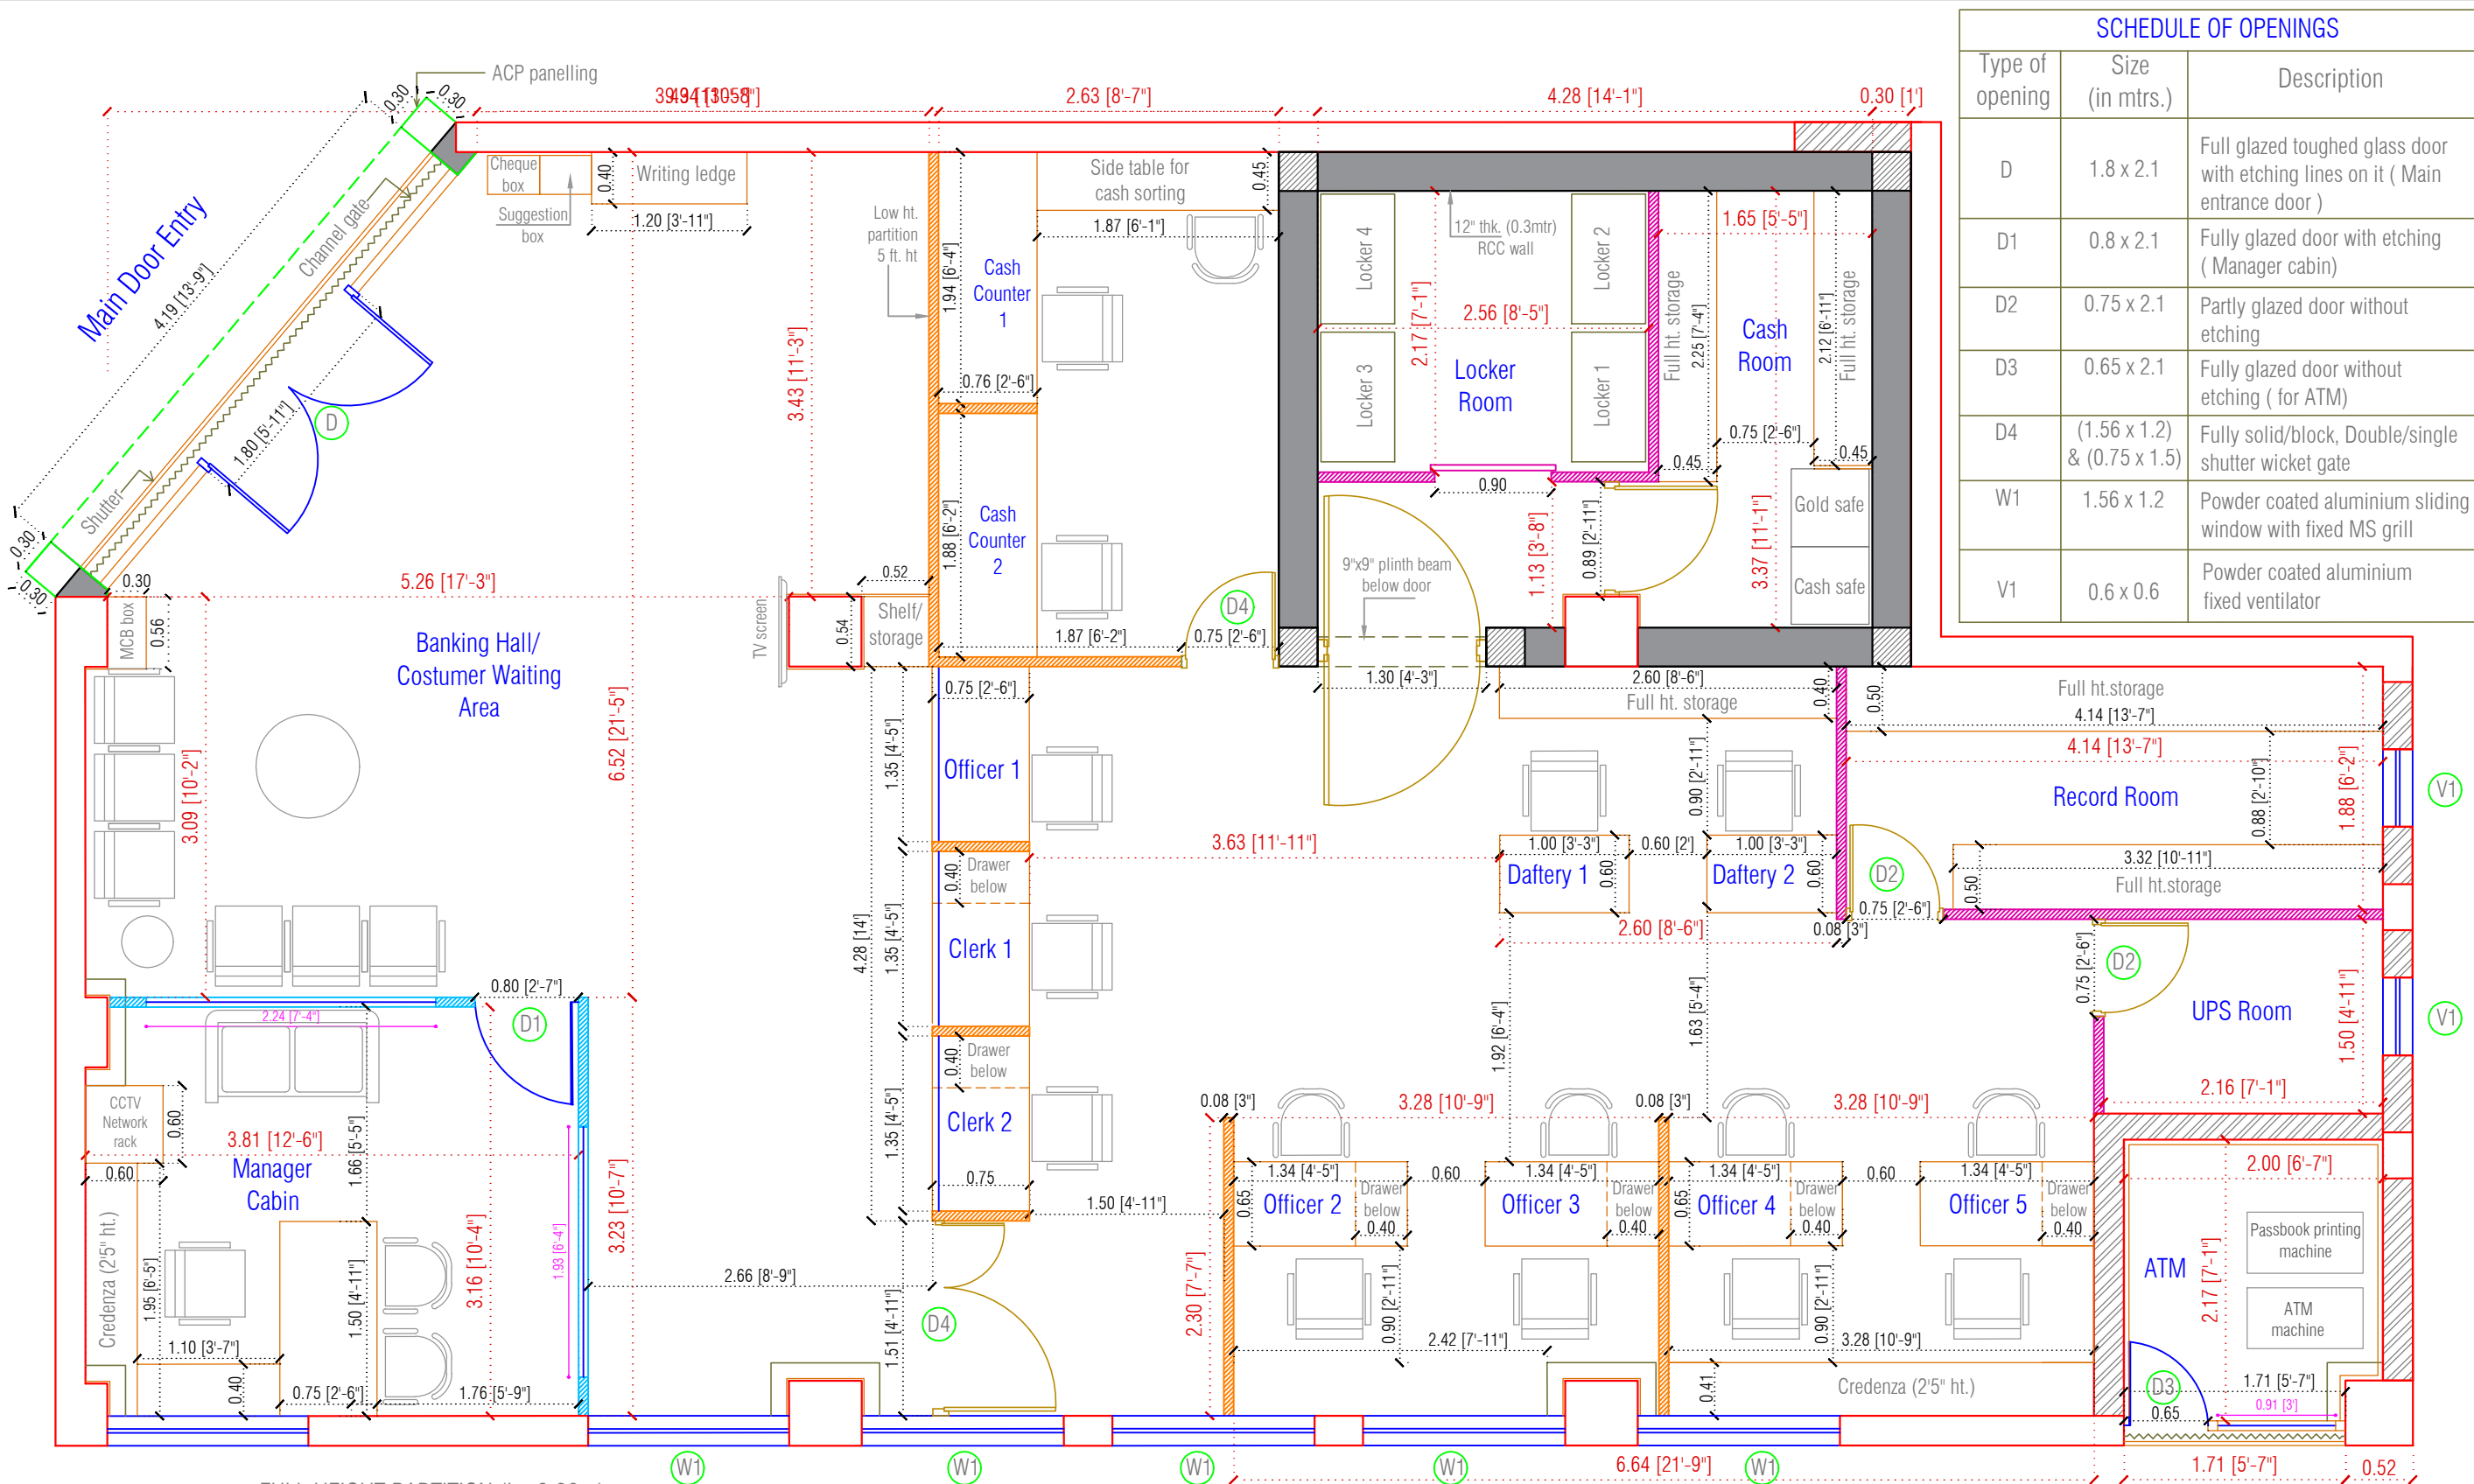

SCHEDULE OF OPENINGS		
Type of opening	Size (in mtrs.)	Description
D	1.8 x 2.1	Full glazed toughed glass door with etching lines on it (Main entrance door)
D1	0.8 x 2.1	Fully glazed door with etching (Manager cabin)
D2	0.75 x 2.1	Partly glazed door without etching
D3	0.65 x 2.1	Fully glazed door without etching (for ATM)
D4	(1.56 x 1.2) & (0.75 x 1.5)	Fully solid/block, Double/single shutter wicket gate
W1	1.56 x 1.2	Powder coated aluminium sliding window with fixed MS grill
V1	0.6 x 0.6	Powder coated aluminium fixed ventilator

PLAN- for MAIN BRANCH OFFICE
 CARPET AREA = 146.40 SQ.M. (1575.84 SQ.FT.)

