



LEGENDS :

	SWITCH BOARD (SB)		TUBE LIGHT (TL)
	WALL LIGHT (WL)		BELL POINT (BP)
	TELEPHONE POINT (TP)		AIR CONDITIONER (AC)
	CEILING LIGHT (CL)		CEILING FAN (CF)

SPECIFICATION FOR ELECTRICAL WORK

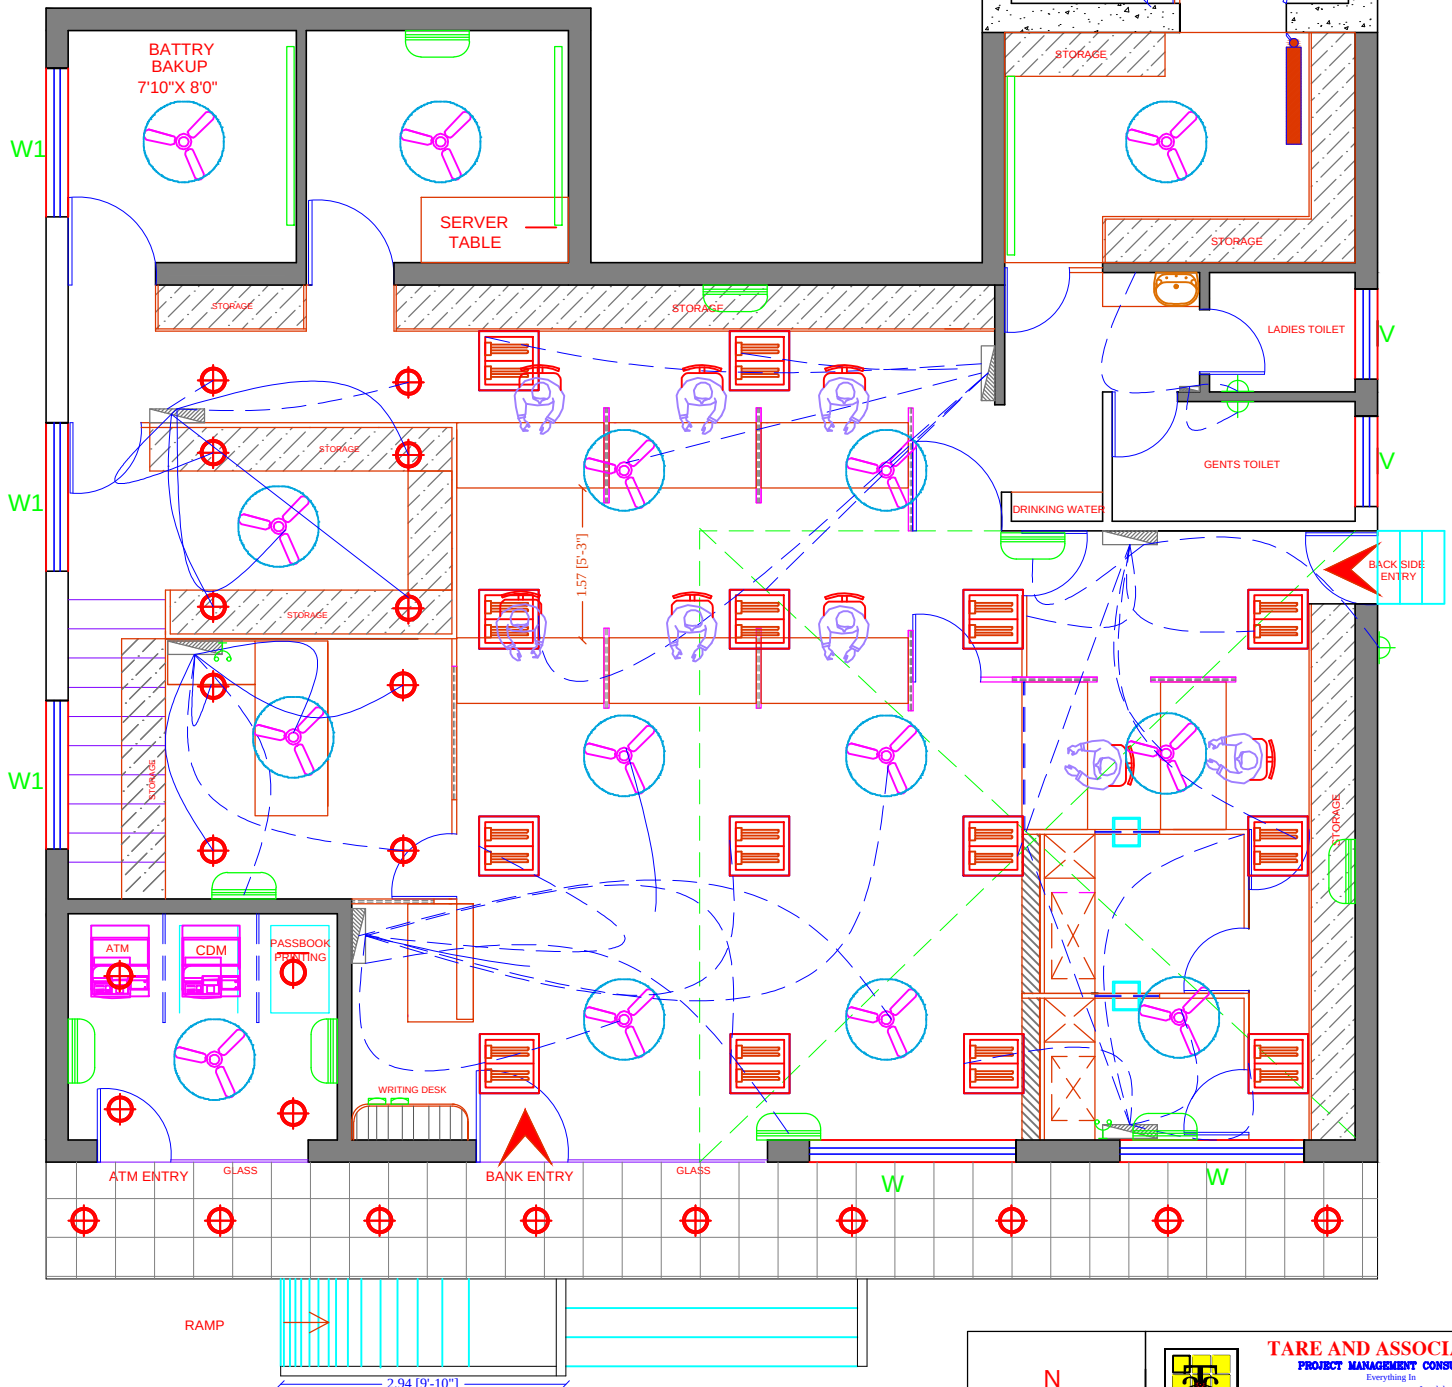

PROPOSED ELECTRICAL LAYOUT OF SANGAMNER BRANCH, FOR BANK OF MAHARASHTRA TAL - SANGAMNER DIST- AHMEDNAGAR.

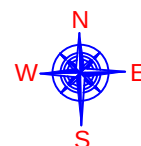

TARE AND ASSOCIATES
PROJECT MANAGEMENT CONSULTANT
Everything in
Buildings, Industries, Structures, Land development,
Landscape, Interiors, Valuation and Arbitration
PH. 0205-2855657 MOB. 98250-58027
E-mail: tpmc@rediffmail.com

Drn. By	MILIND TARE	Job No.	Drg. No.
Chd. By	MILIND TARE	61	02
Scale	1:100		
Date	17.09.2018		